


GROUND FLOOR PLAN:

MEZZANINE LEVEL PLAN:

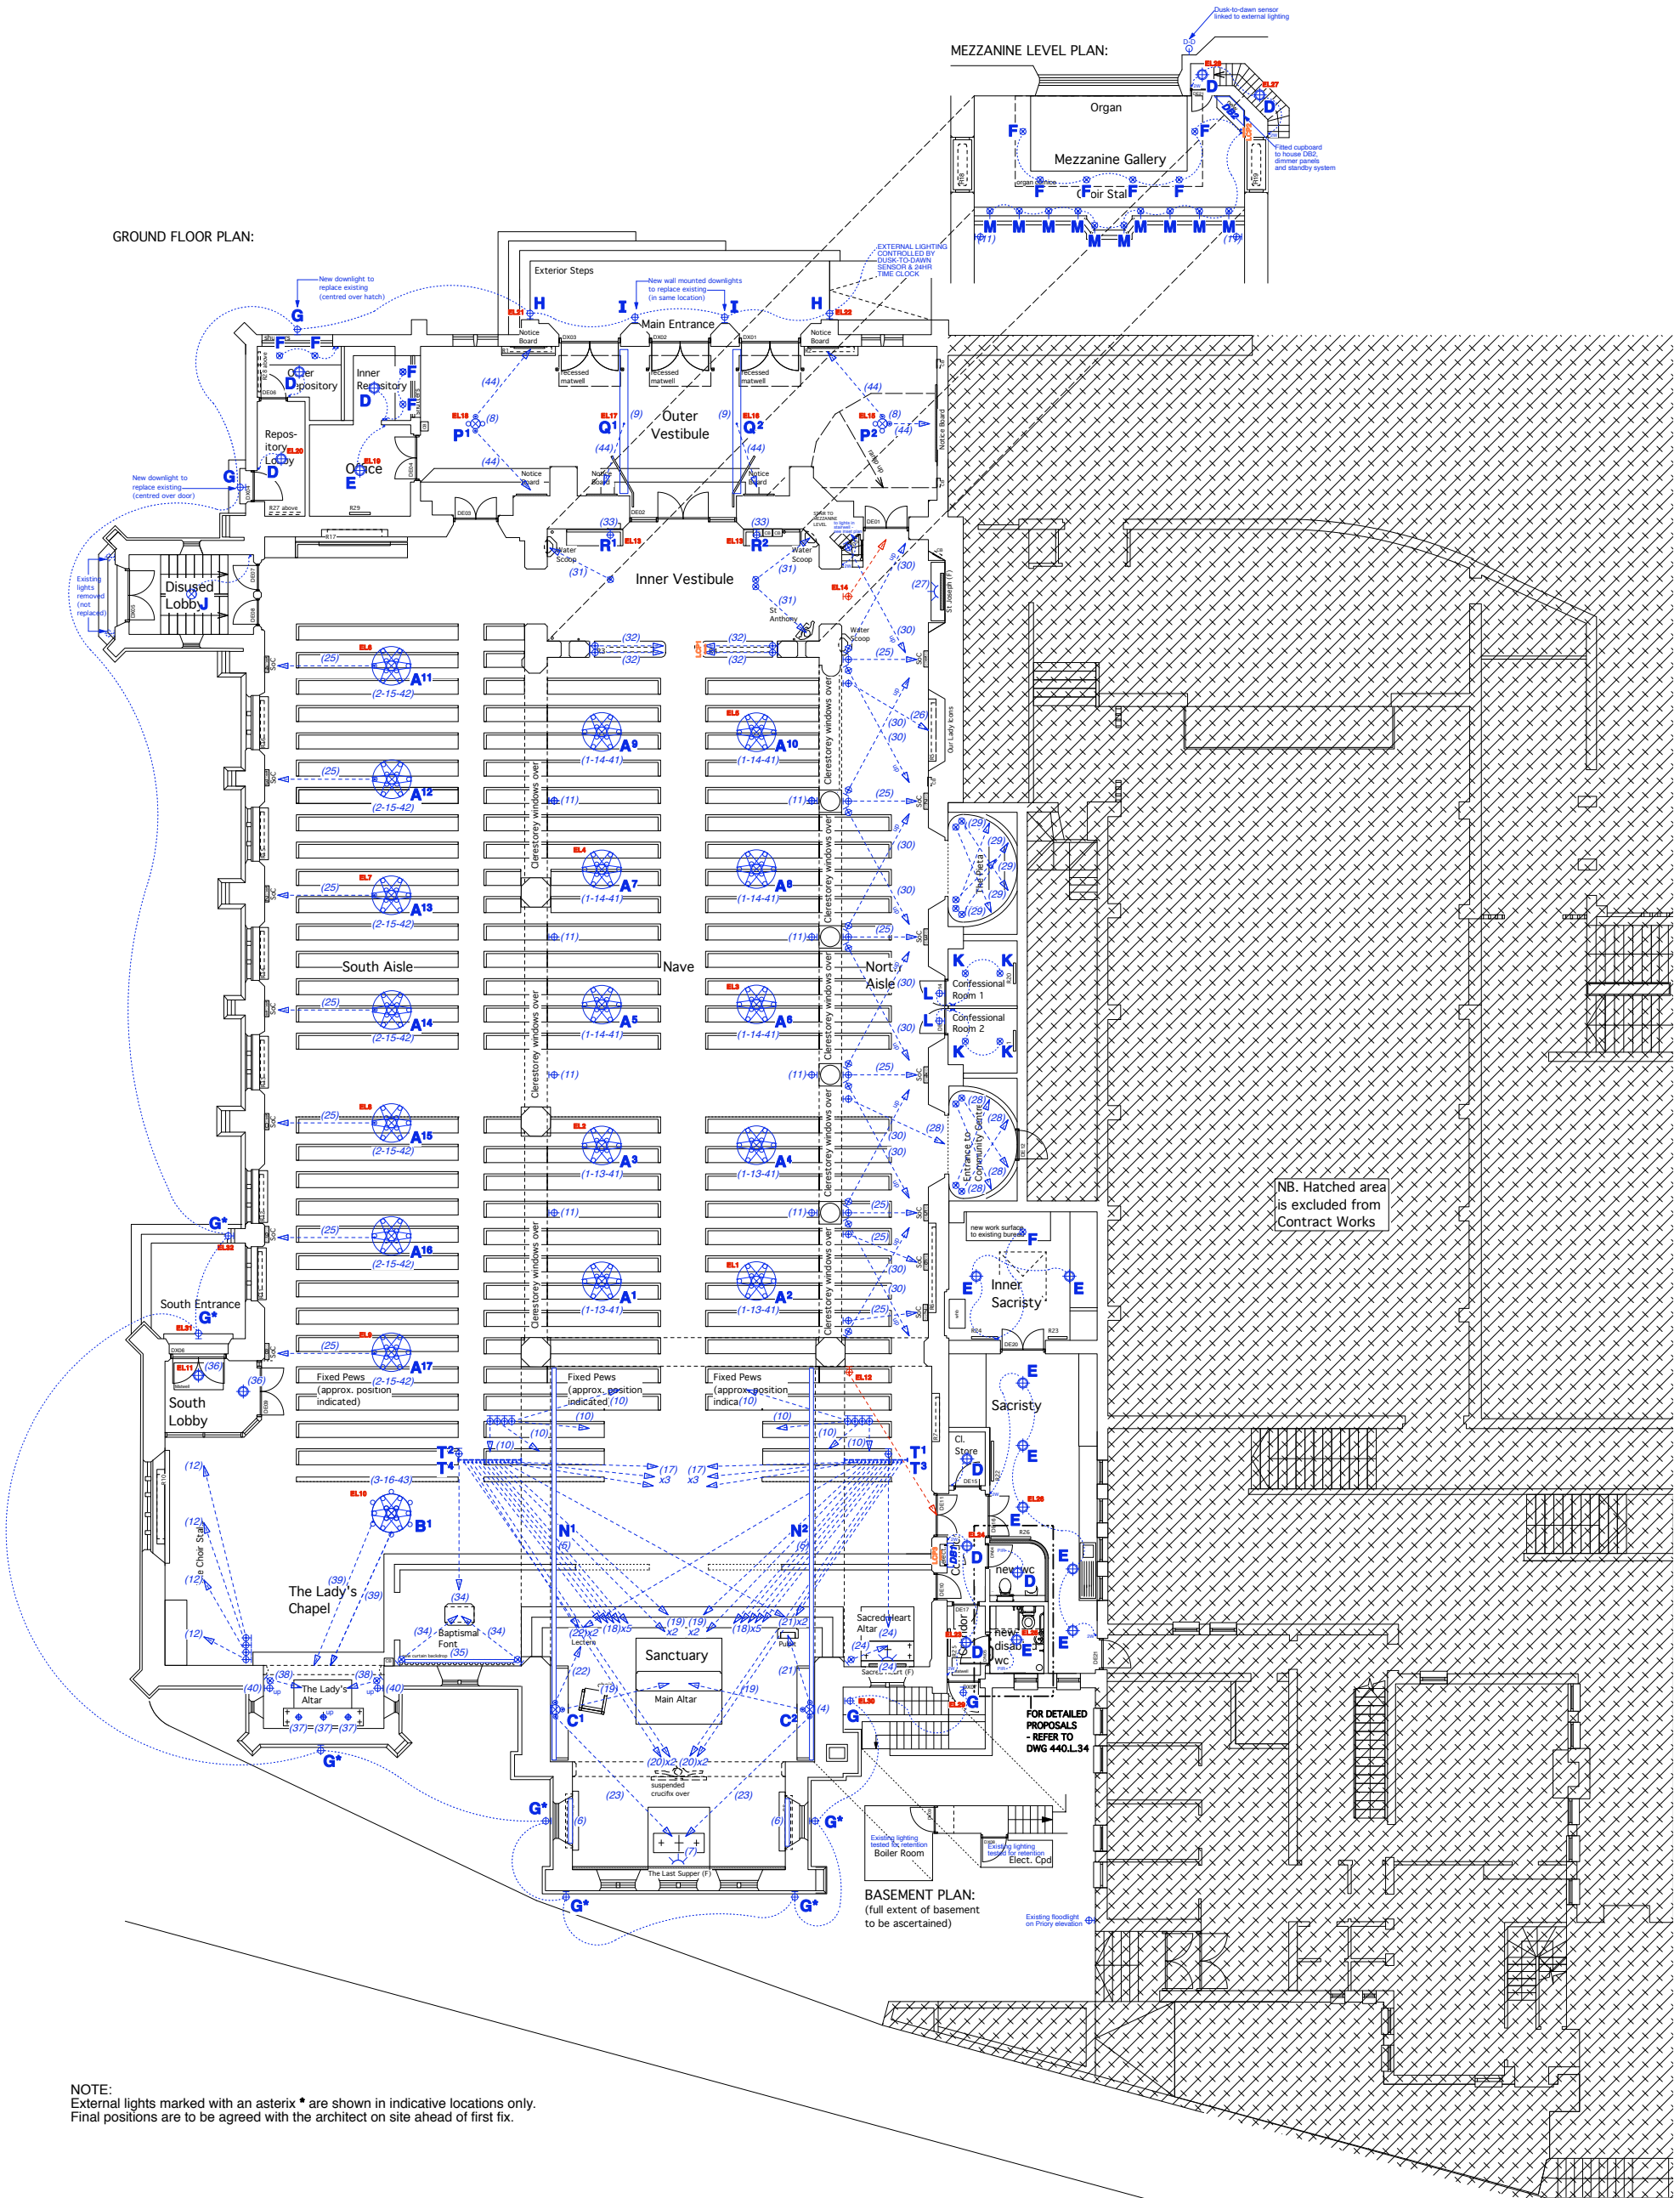

NOTE:  
External lights marked with an asterisk \* are shown in indicative locations only.  
Final positions are to be agreed with the architect on site ahead of first fix.

NOTES:

1. This drawing is based upon previous design plan drawings and is not based upon a complete measured survey of the existing building. Any discrepancies identified between this plan drawing and the as-built building fabric should be brought to the Architect's attention.
2. Setting out is indicative of design intent. Precise locations of all fittings and wiring route(s) to be confirmed on site ahead of first fix.
3. To be read in conjunction with the Electrical Engineer's Specification, Schedules and Scope of Works.

Revisions C0 - 27/04/12 - Issued for Construction

Title Sacred Heart Catholic Church, Quex Road, London NW6  
PLAN: Proposed Lighting Layout

Brady Mallalieu Architects  
90 Queens Drive, London N4 2HW

Scale 1:100/A1  
1:200/A3  
Date November 11

Drawing No. 440.L.021 rev.C0

T +44 (0)20 8880 1544  
F +44 (0)20 8880 2687  
bma@bradymallalieu.com

All dimensions to be checked on site. Do not scale off this drawing. This drawing is copyright.