


GROUND FLOOR PLAN:

MEZZANINE LEVEL PLAN:

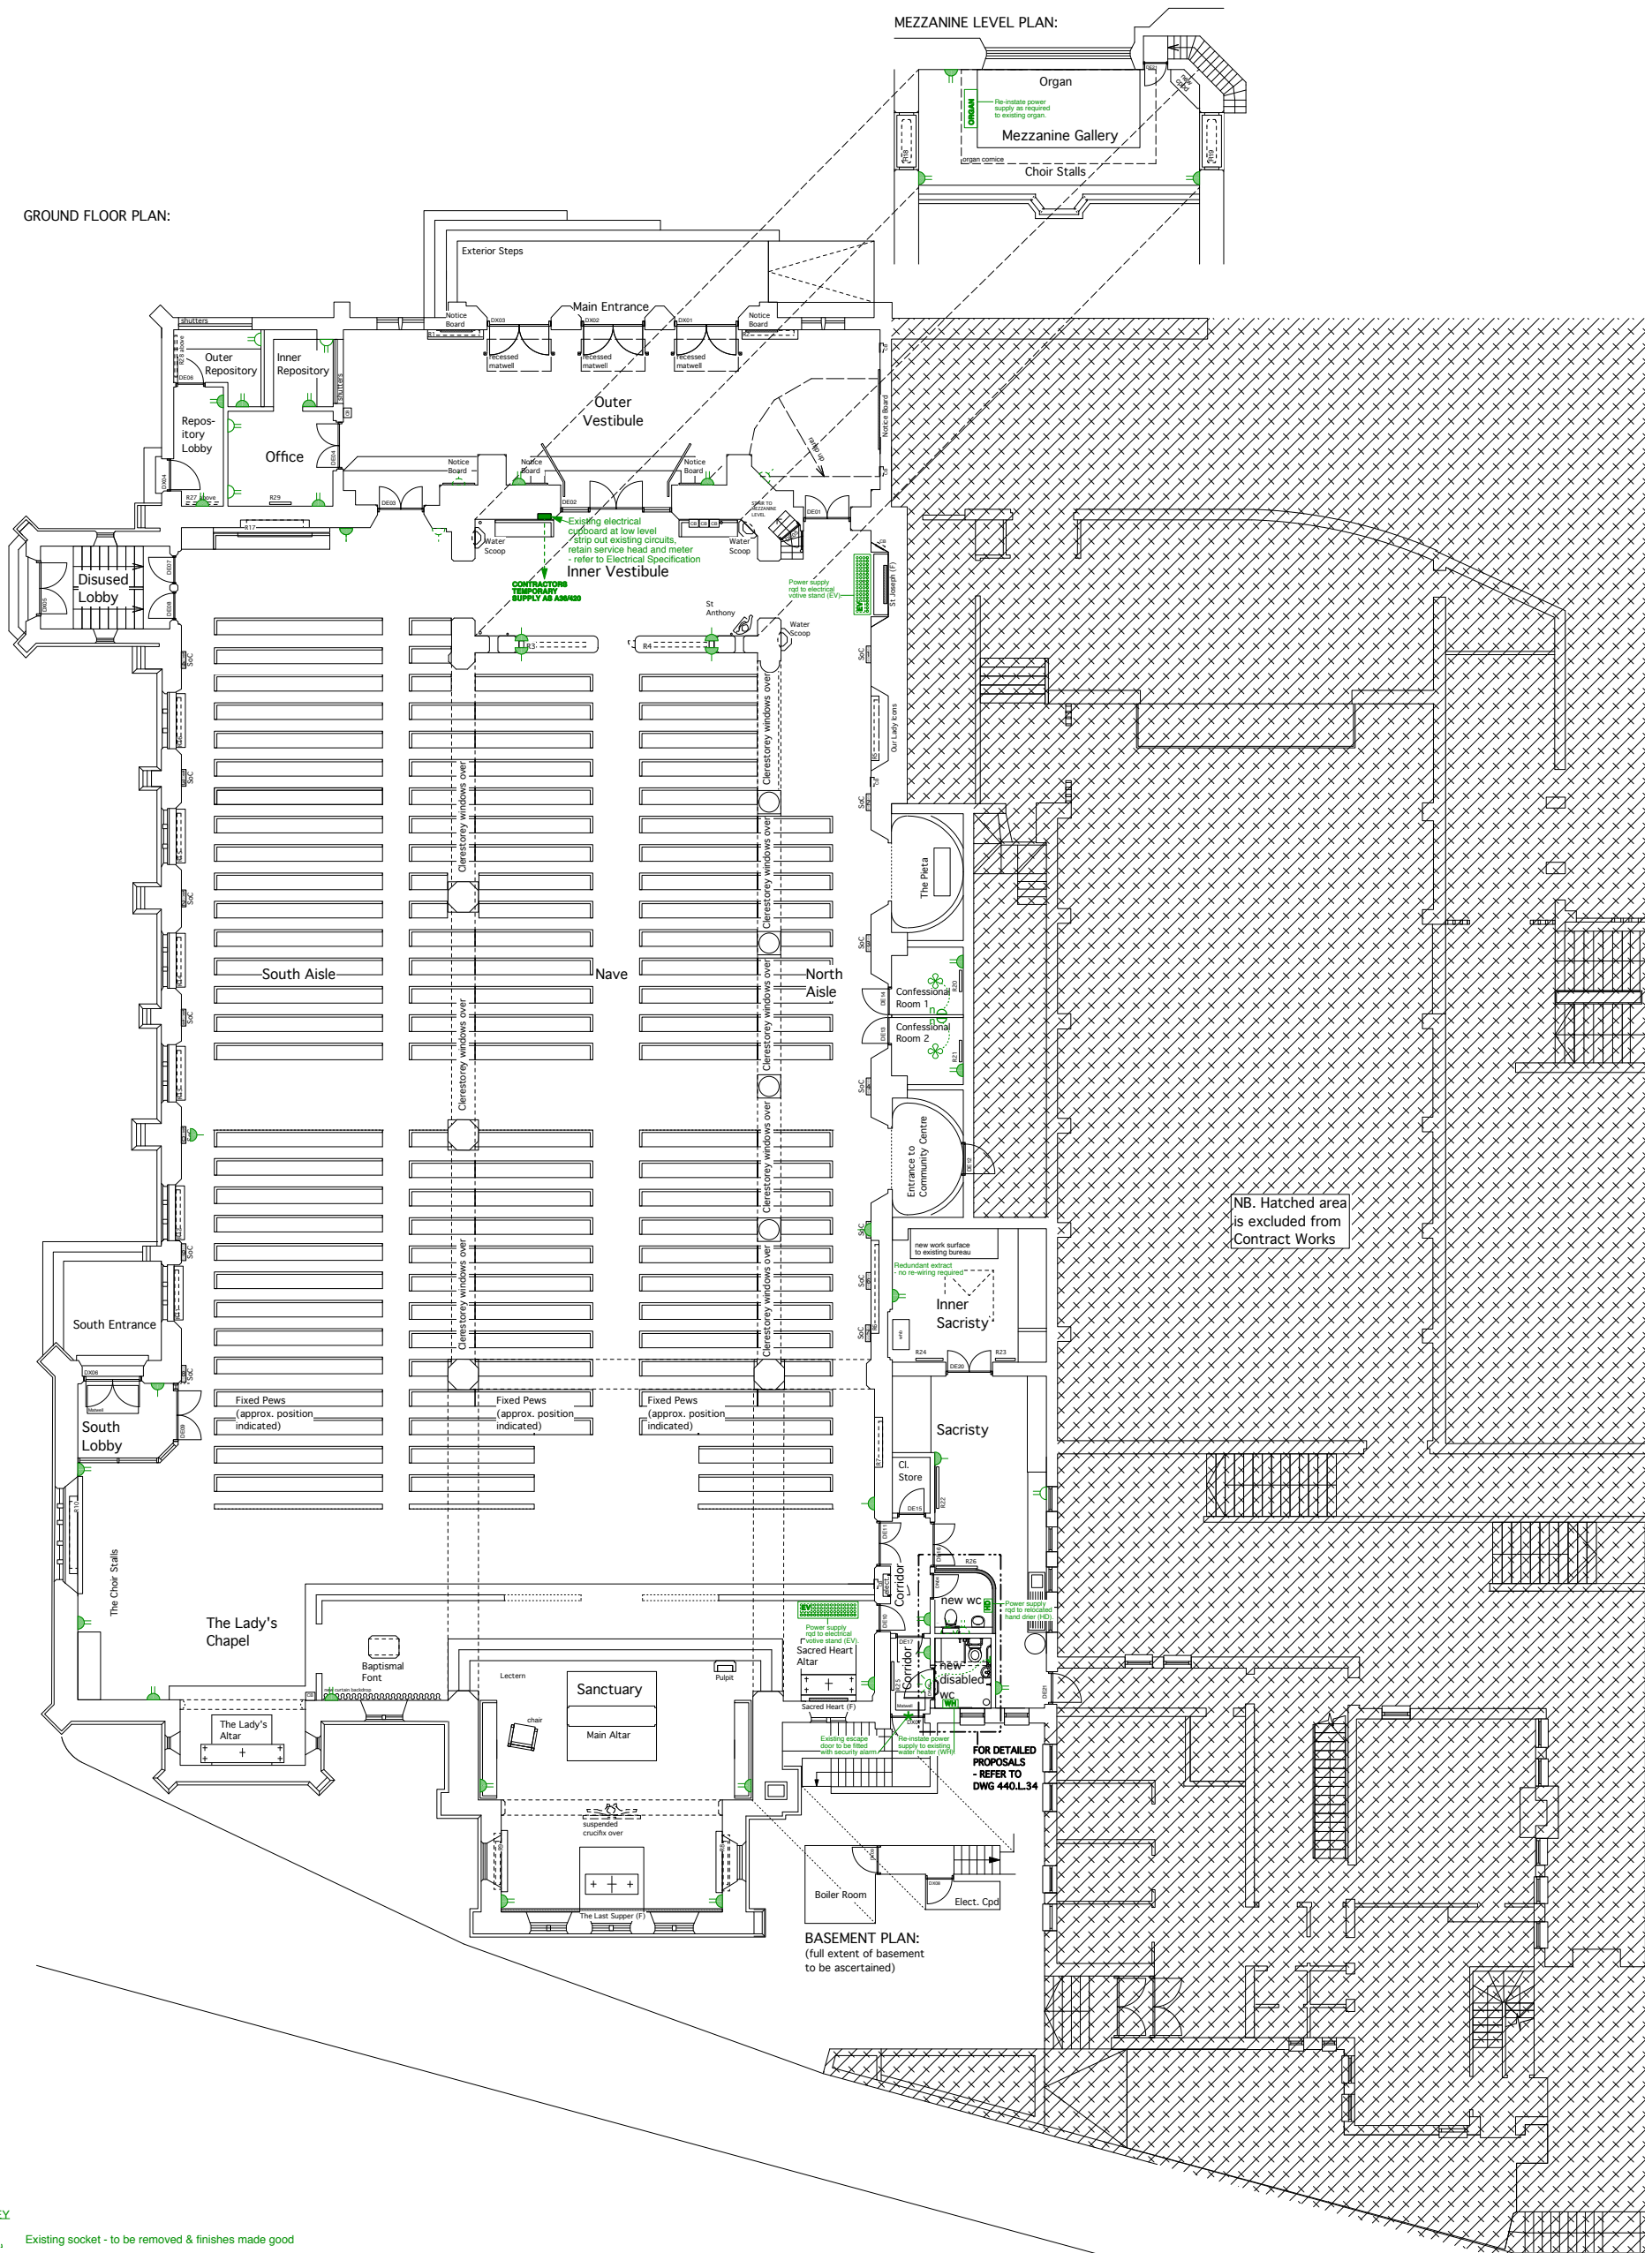

- KEY:**
- Existing socket - to be removed & finishes made good
 - Single switched socket outlet - typically recessed into wall unless otherwise noted
 - Double switched socket outlet - typically recessed into wall unless otherwise noted
 - Telephone point
 - Switched spur with neon indicator
 - Existing extract ventilation - ceiling mounted extract
 - Existing water heater/hand drier - elect. supply required
 - Existing door to be alarmed
 - Existing electric votives - elect. supply required
 - New disabled wc alarm - pull cord inside wc & beacon outside

- NOTES:**
1. This drawing is based upon previous design plan drawings and is not based upon a complete measured survey of the existing building. Any discrepancies identified between this plan drawing and the as-built building fabric should be brought to the Architect's attention.
 2. Setting out is indicative of design intent. Precise locations of all fittings and wiring route(s) to be confirmed on site ahead of first fix.
 3. To be read in conjunction with the Electrical Engineer's Specification, Schedules and Scope of Works.

Revisions CO - 27/04/12 - Notes added re: electrical supply to Inner Vestibule. Issued for Construction.

Title Sacred Heart Catholic Church, Quex Road, London NW6
PLAN: Proposed Small Power Layout
 Scale 1:100/A1
 1:200/A3
 Date November 11

Brady Mallalieu Architects
 90 Queens Drive, London N4 2HW
 T +44 (0)20 8880 1544
 F +44 (0)20 8880 2687
 bma@bradmallalieu.com

Drawing No. **440.L.022** rev. CO
 FOR DETAILED PROPOSALS - REFER TO DWG 440.L.34
 All dimensions to be checked on site. Do not scale off this drawing. This drawing is copyright.