


GROUND FLOOR PLAN:

MEZZANINE LEVEL PLAN:

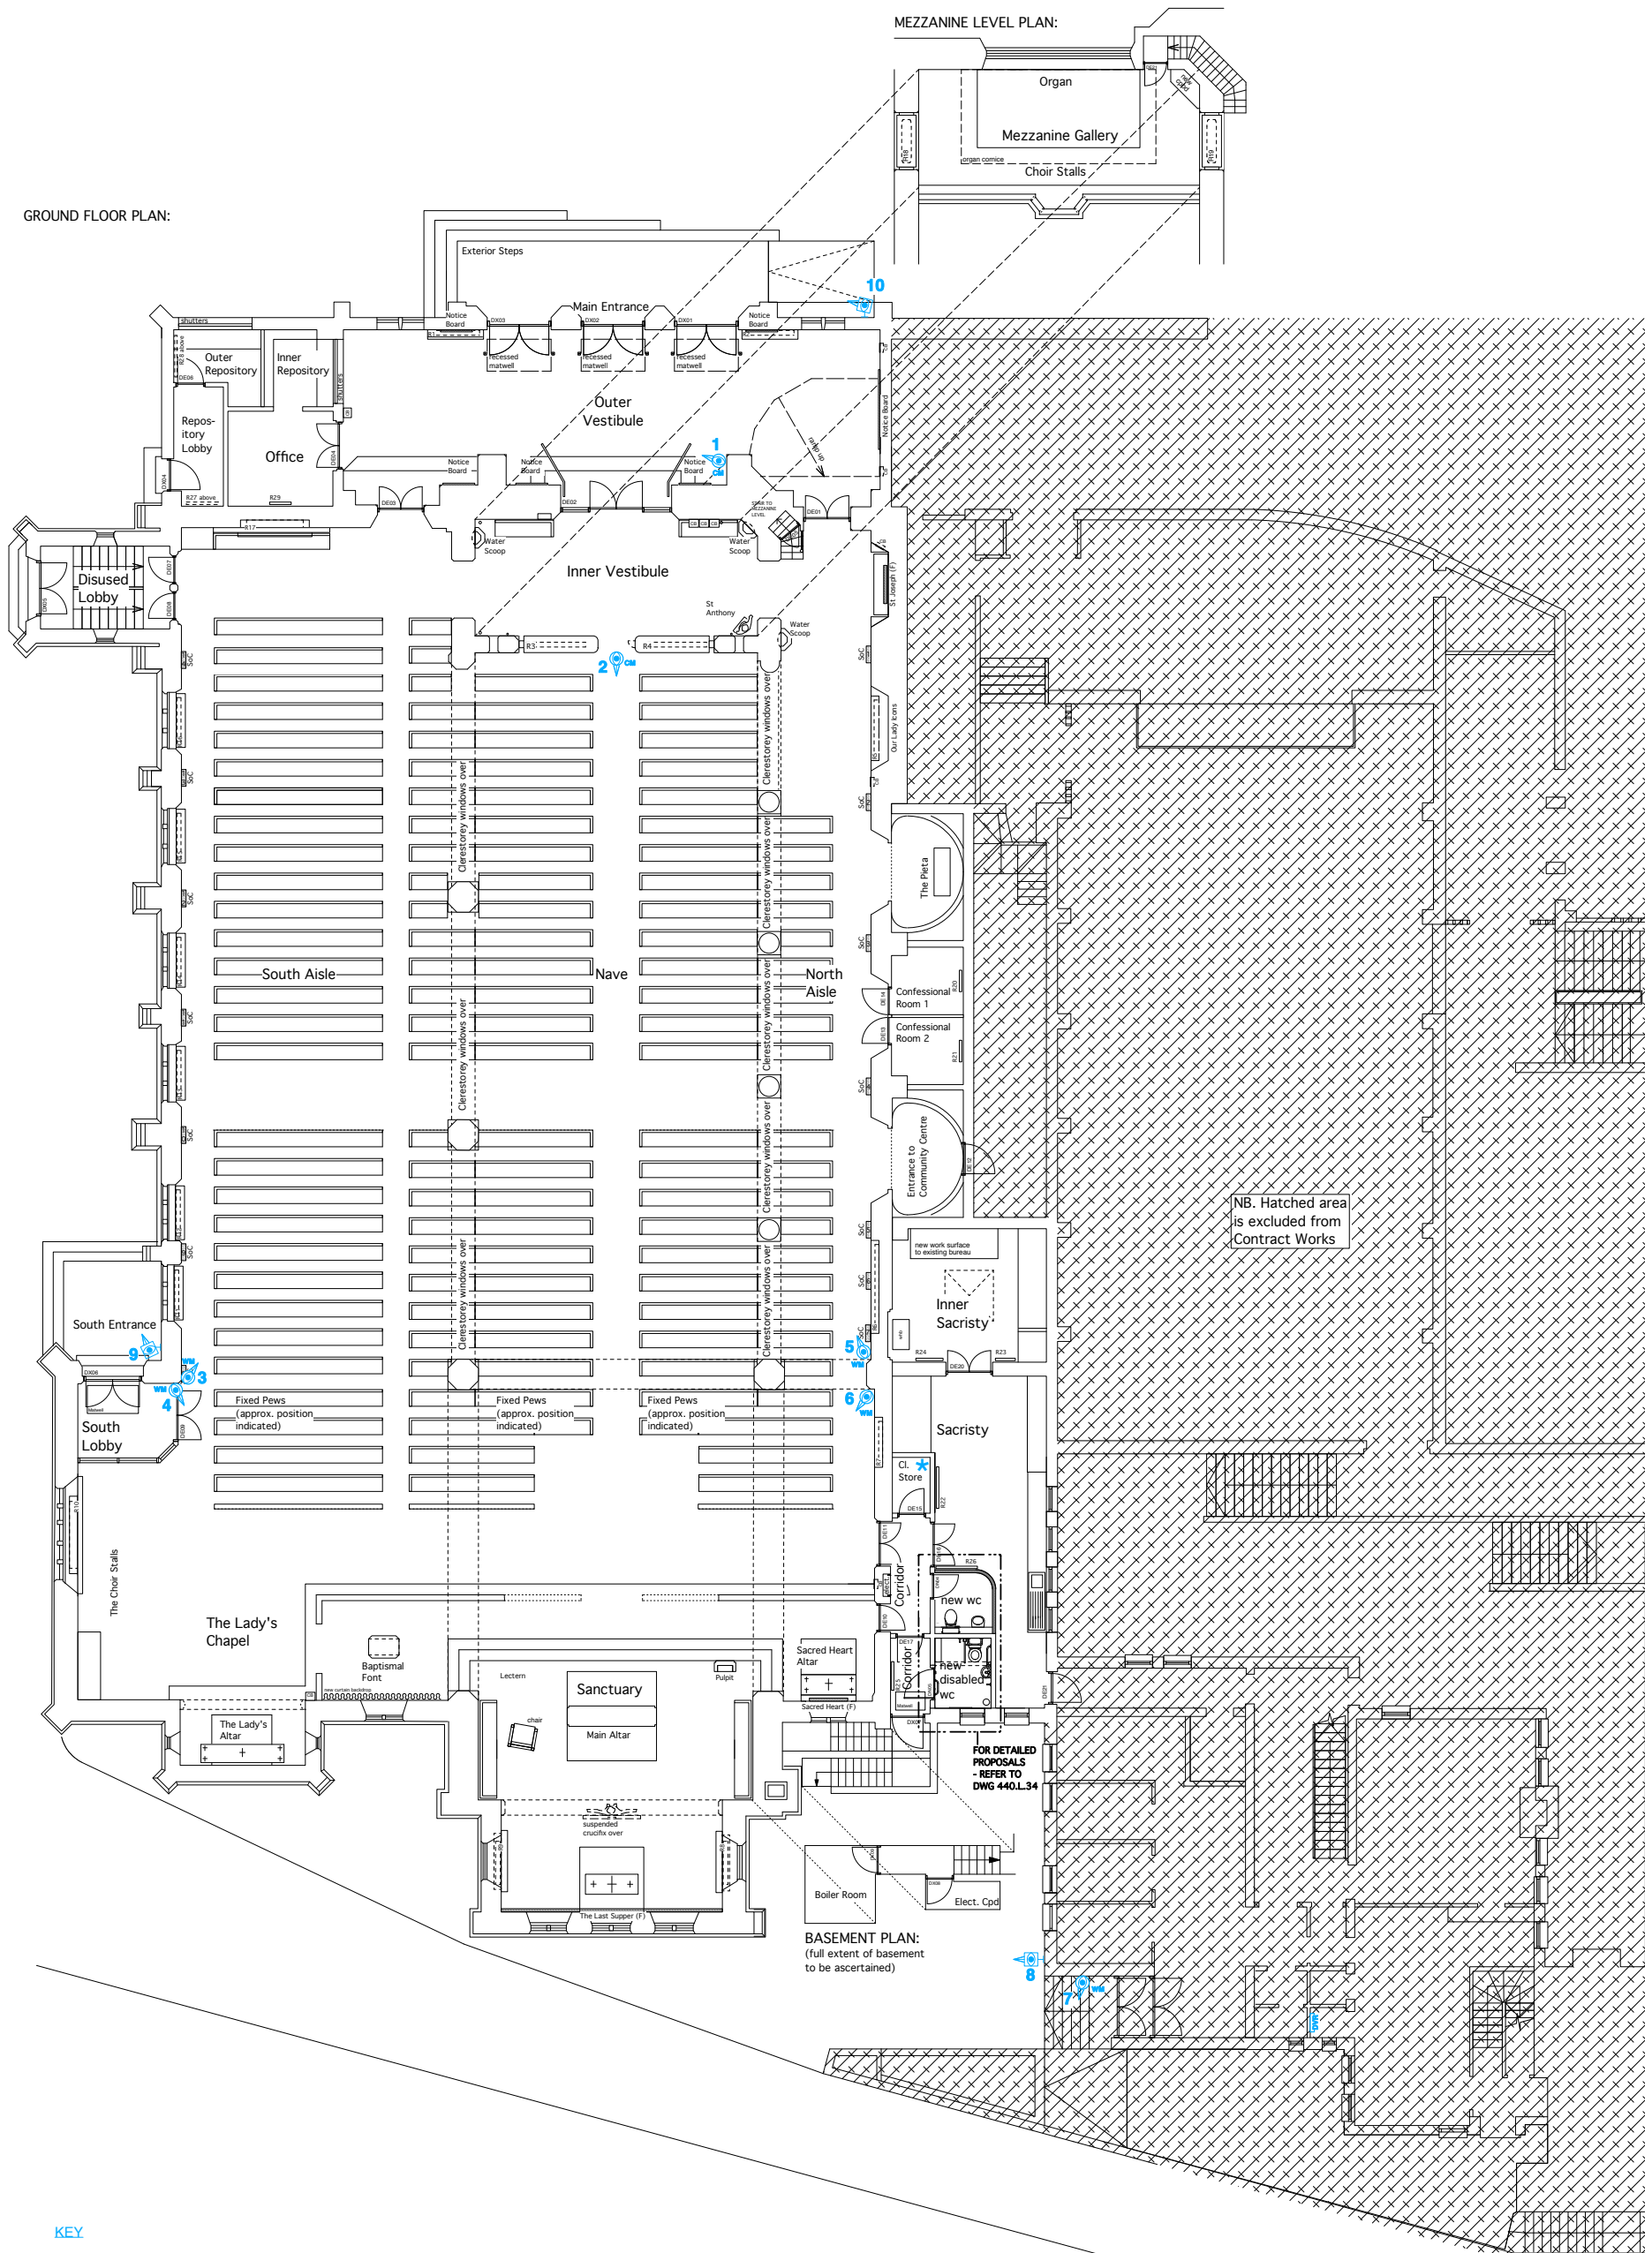

NB. Hatched area is excluded from Contract Works

FOR DETAILED PROPOSALS - REFER TO DWG 440.L.34

BASEMENT PLAN: (full extent of basement to be ascertained)

- KEY**
- Camera Ref. No. - cross reference with specification document
 - CCTV Dome Camera - ceiling mounted
 - CCTV Dome Camera - wall mounted
 - External CCTV Camera - wall mounted
 - Power Supply Point - to be confirmed on site
 - Digital Video Recorder

- NOTES:**
1. This drawing is based upon previous design plan drawings and is not based upon a complete measured survey of the existing building. Any discrepancies identified between this plan drawing and the as-built building fabric should be brought to the Architect's attention.
 2. Setting out is indicative of design intent. Precise locations of all fittings and wiring route(s) to be confirmed on site ahead of first fix.
 3. To be read in conjunction with the Electrical Engineer's Specification, Schedules and Scope of Works.

Revisions CO - 27/04/12 - Issued for Construction.

Title Sacred Heart Catholic Church, Quex Road, London NW6
PLAN: Proposed CCTV Layout
 Scale 1:100/A1
 1:200/A3
 Date November 11
 Drawing No. **440.L.024** rev. CO

Brady Mallalieu Architects
 90 Queens Drive, London N4 2HW
 T +44 (0)20 8880 1544
 F +44 (0)20 8880 2687
 bma@bradmallalieu.com

All dimensions to be checked on site. Do not scale off this drawing. This drawing is copyright.